




Acer International Fire Alarm Works

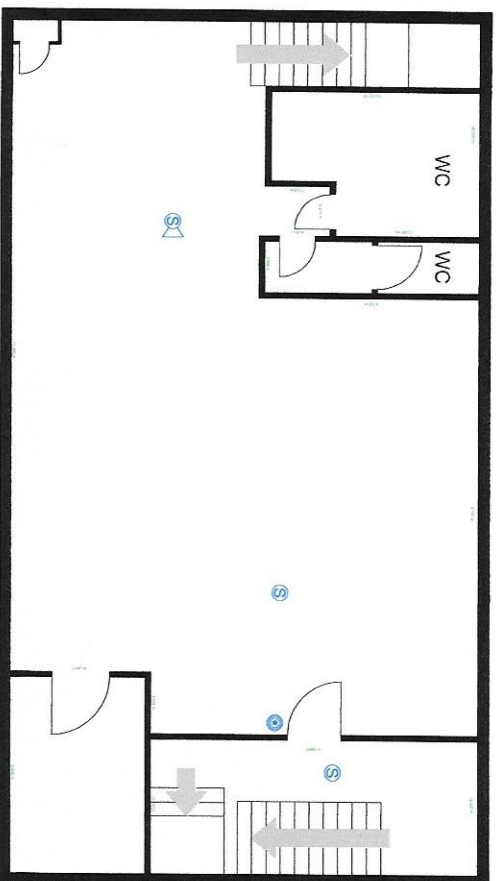

First Floor

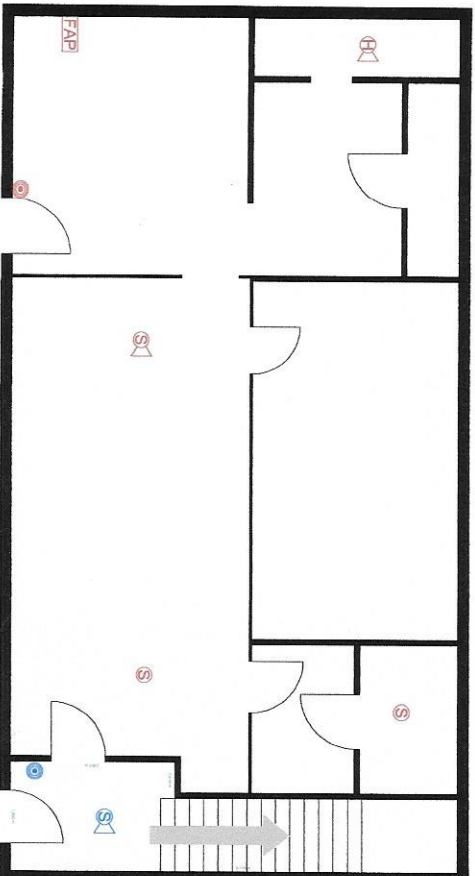

Ground Floor

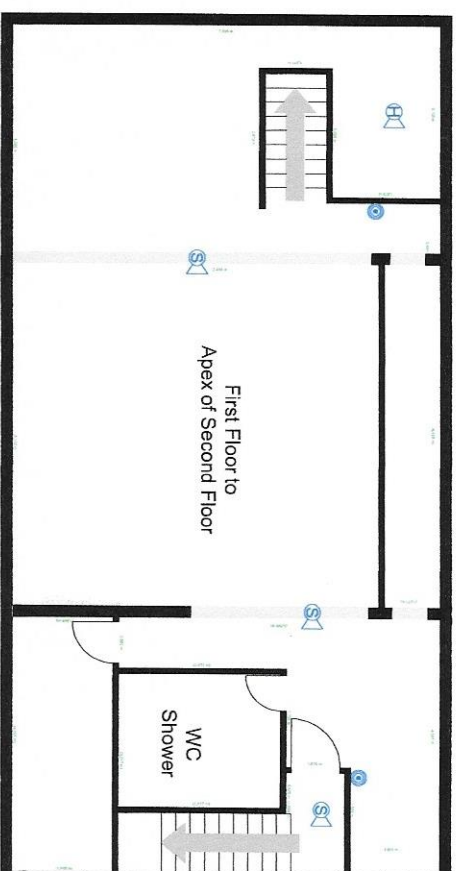


Second Floor

Fire Alarm Legend	
FAP	Fire Alarm Panel to Keep
	Manual Call Point to Keep
	Optical Smoke Detector to Keep
	Optical Smoke Detector to Keep
	Heat Detector cw Sounder Base to Keep
	Manual Call Point to Remove
	Optical Smoke Detector to Remove
	Optical Smoke Detector to Remove
	Heat Detector cw Sounder Base Remove

Date	29th September 2021	Drawn by	Shane Fay
Drawing	Acer International 214028 Rev0.dwg	Revision	Rev0
Client	Acer International Ltd	Scale	NTS

13-15 Canfield Place - First Floor - Proposed Layout Plan

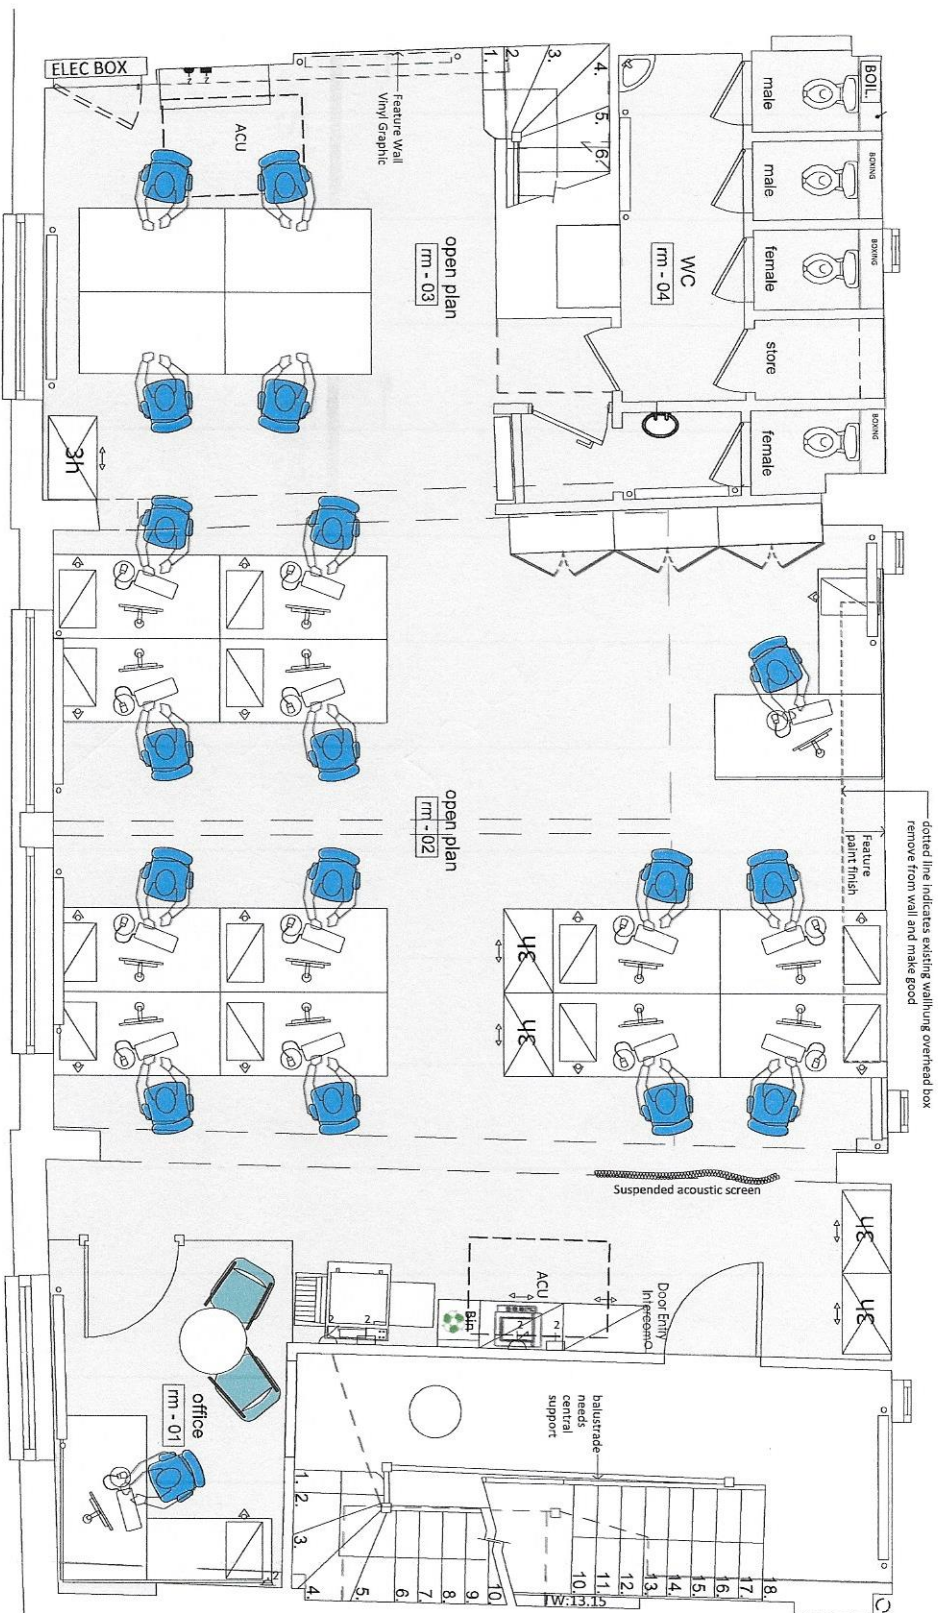

This floor accommodates:
 1 Office
 1 Teapoint
 1 Unisex WC
 1 Copy/Print
 17 Open plan workstations

Approximately 102 SQM in total (excluding staircase)

Notes:

Notes:

Notes:

For information

ACER

13-15 Canfield Place

London

NW6 3BT

Proposed Layout Plan

First Floor

1:50 @ A3


ACER/101/201A




GO Constructive Space Ltd
 www.constructivespace.com
 Tel: 0203 408970

Notes:

notes

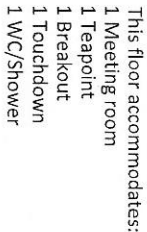

13-15 Canfield Place - Second Floor - Proposed Layout Plan

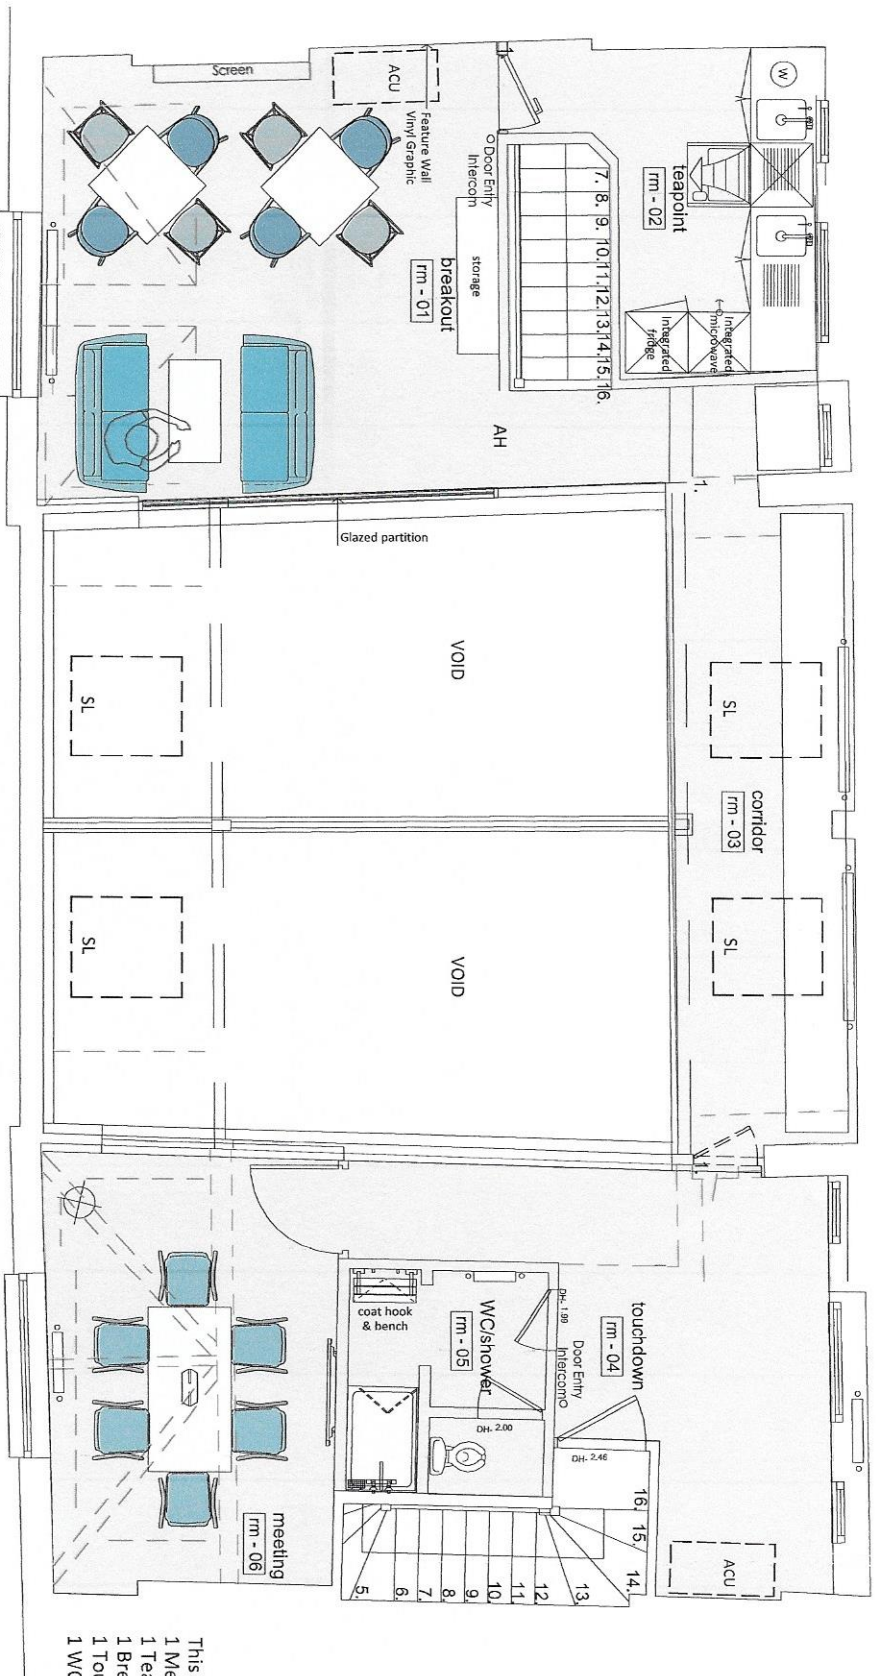

This floor accommodates:
 1 Meeting room
 1 Teapoint
 1 Breakout
 1 Touchdown
 1 WC/Shower

Approximately 70.2 SQM in total (excluding staircase)

notes :

notes :

notes :

for information

DATE: 24.02.17 BY: SP FIRST ISSUE

A: 28.02.17 SP REVISED LAYOUT PLAN

B: 02.03.17 SP FURTHER REVISED

ACER

13-15 Canfield Place

London

NW6 3BT

Proposed Layout Plan

Second Floor

150 @ A3


ACER/L02/2018



60 Greatman Street, London, EC2V 7BB
 www.constructivespace.com
 info@constructivespace.com
 Tel: 0203 4408970

notes :

13-15 Canfield Place - Ground Floor - Proposed Layout Plan- Opt 01

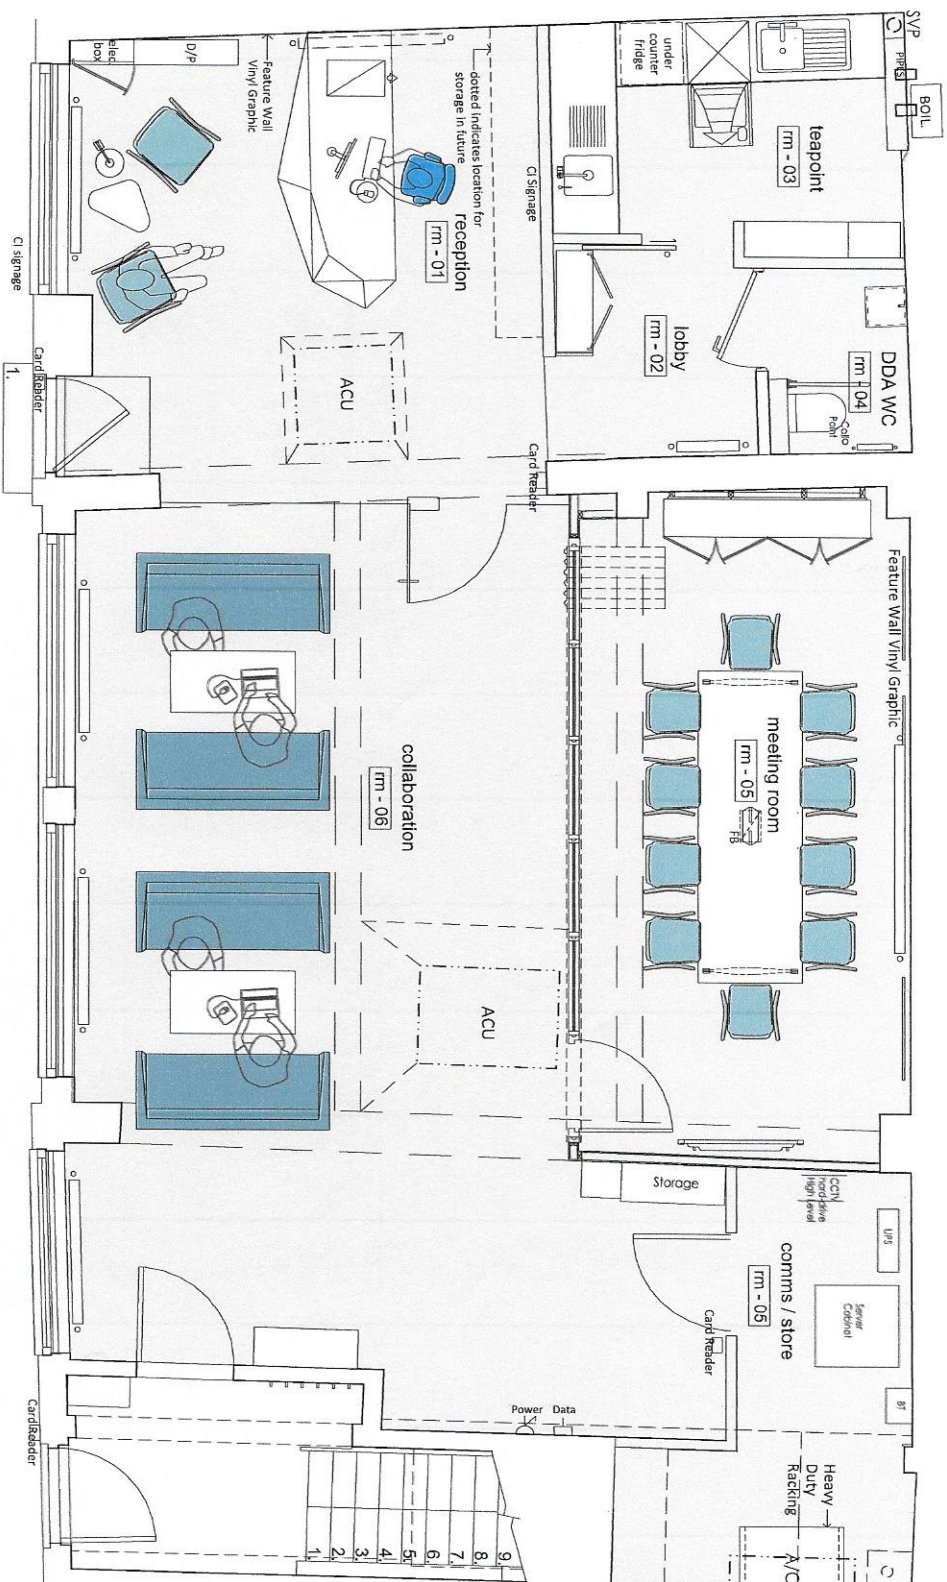

Approximately 109.5 SQM in total (excluding staircase)

notes ;

notes ;

notes :

for information

issue	date	by	comments	approved
O	24.02.17	Sp	first issue	
A	28.02.17	Sp	revised layout plan	

do not arise from crawling, all discrepancies to be reported to the designer immediately, all dimensions are subject to site checks, this drawing is the copyright of Commercially Licensed and may not be reproduced in any form without prior written consent

ACER

13-15 Canfield Place
London
NW6 3BT

1:50 @ A3

ACER/L00/201A

This floor accommodates:

- 1 Reception
- 1 Teapoint
- 1 DDA WC
- 1 Meeting room
- 4 Meeting Pods
- 1 Comms / Store

notes :



60 Gresham Street, London, EC2V 7BE
www.constructivespace.com
info@constructivespace.com
tel. 0203 4409870